




REVISIONS			
REV	DESCRIPTION	DATE	APPROVED

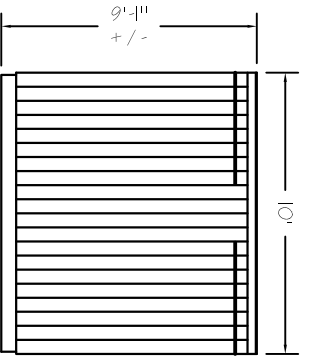


ELEVATION 3

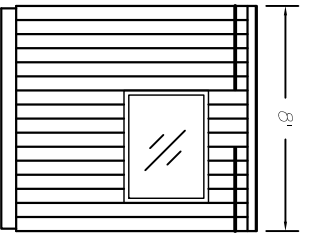


ELEVATION 4

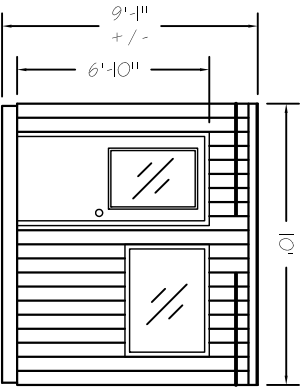

ELEVATION 1

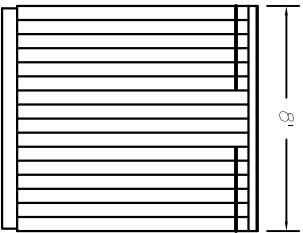


ELEVATION 2

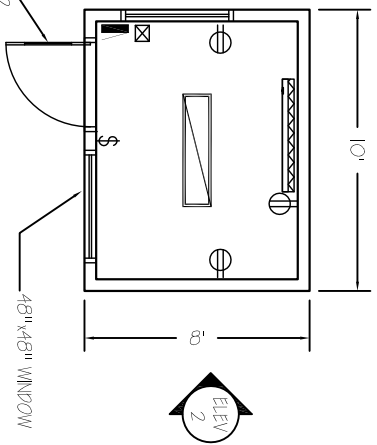

FLOOR PLAN

Building may not be exactly as shown

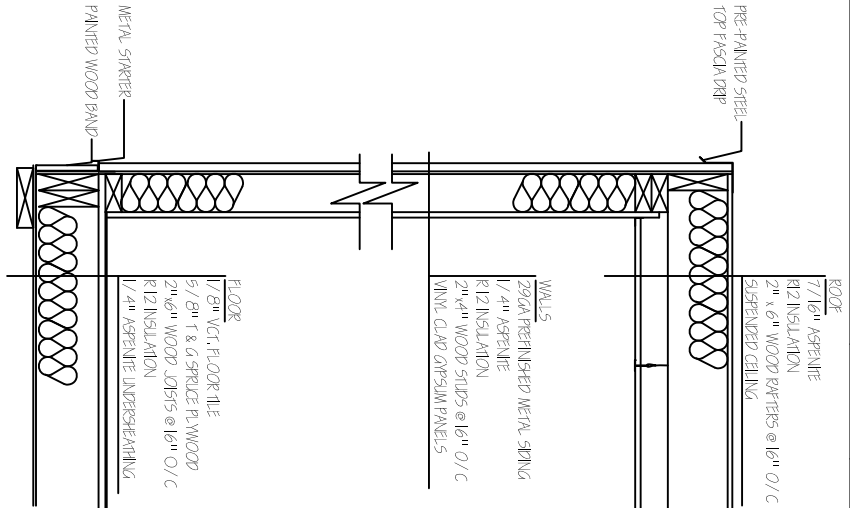

SECTION 1

- ELECTRICAL LEGEND:**
- (1) 1x4' FLUORESCENT LIGHT FIXTURE
 - (3) DUPLEX RECEPTACLES
 - (1) SINGLE POLE LIGHT SWITCH
 - (1) JUNCTION BOX MOUNTED ON ROOF
 - (1) 100 amp SINGLE PHASE CIRCUIT BREAKER PANEL
 - (1) 1 KW BASE BOARD HEATER

CUSTOMER:		BY: A.M.	
LOCATION:		YR	MO
Mississauga		10	03
JOB NAME:		10	03
8'x10' PRE-ASSEMBLED BUILDING W/1		10	03
DWG./JOB NO.:	SCALE: N.T.S.	REVNO	
QUOTE NO.:			
SHEET NO.:			

