
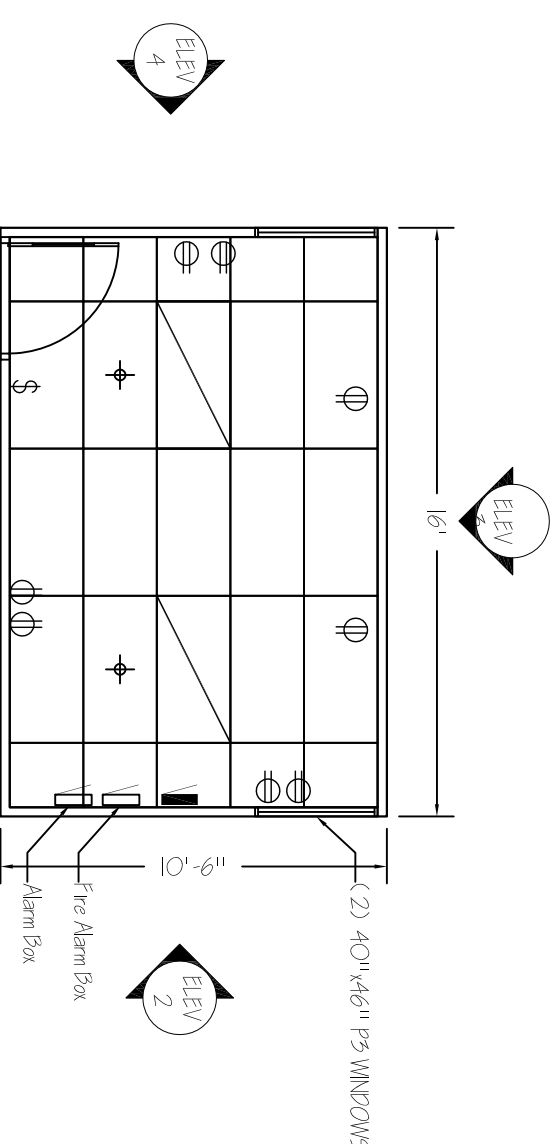
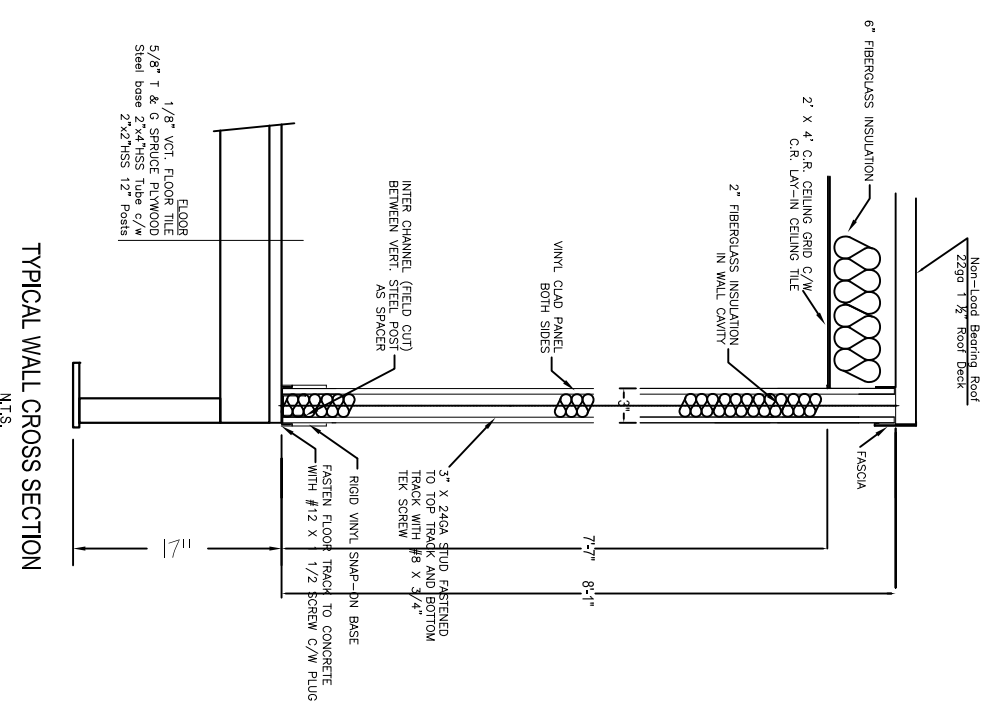
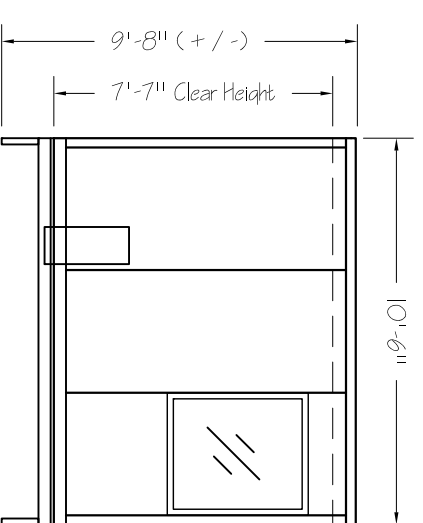
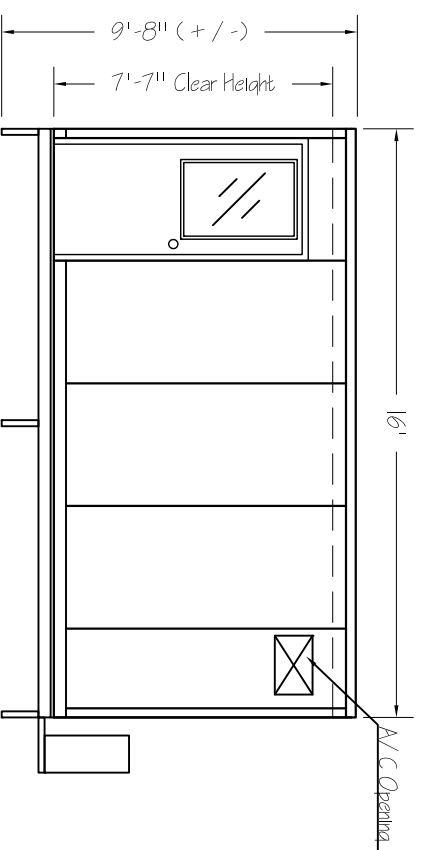
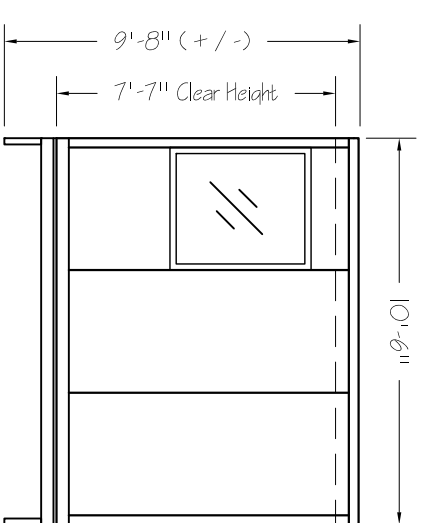



REVISIONS		
REV	DESCRIPTION	APPROVED

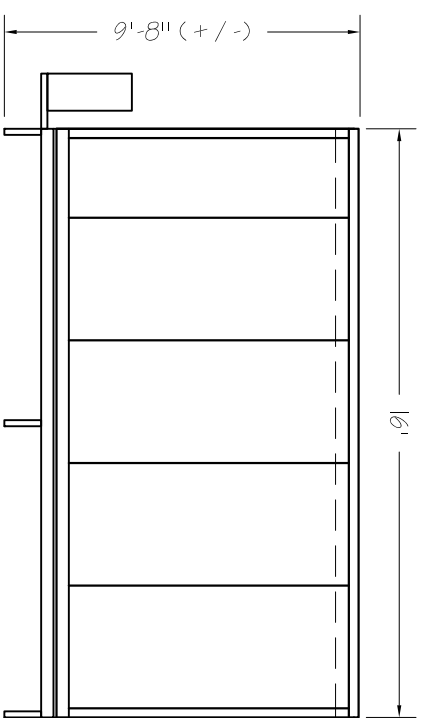

ELECTRICAL LEGEND:

- (2) 2x4' FLUORESCENT LIGHT FIXTURE
- (8) DUPLEX RECEPTACLES
- (1) SINGLE POLE LIGHT SWITCH
- (1) 100 amp SINGLE PHASE CIRCUIT BREAKER PANEL
- (2) SPRINKLER HEAD

CUSTOMER:			
LOCATION:		Mississauga , ONT	
JOB NAME:		10'x16' PRE-ASSEMBLED SYS40 INT. BUILDING	
DWG/JOB NO.:		BY: A.M.	
QUOTE NO.:		YR	MO
SHEET NO.:		10	09
SCALE: N.T.S.		REV/NO	0

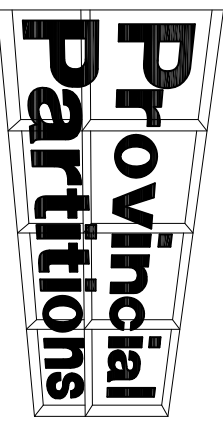

Building may not be exactly as shown