
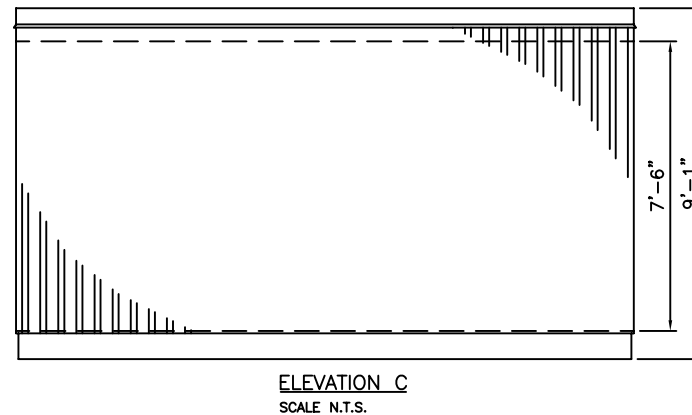
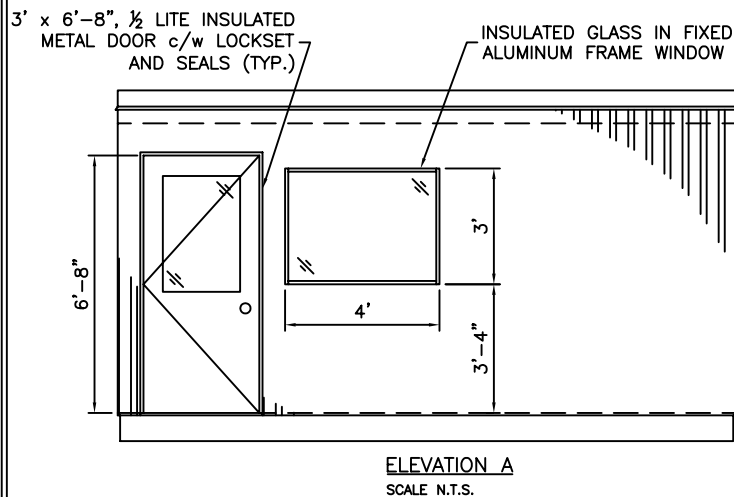
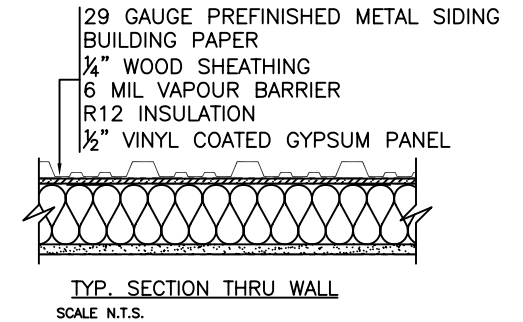
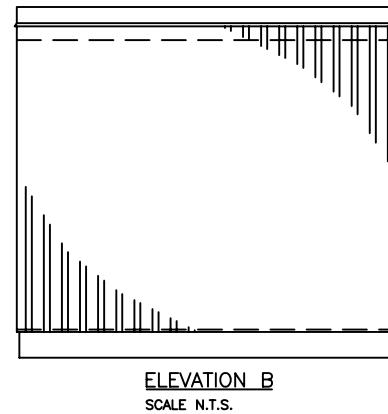
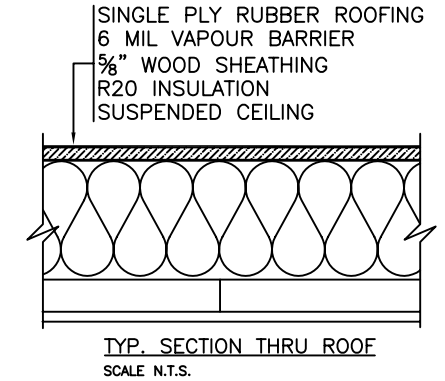
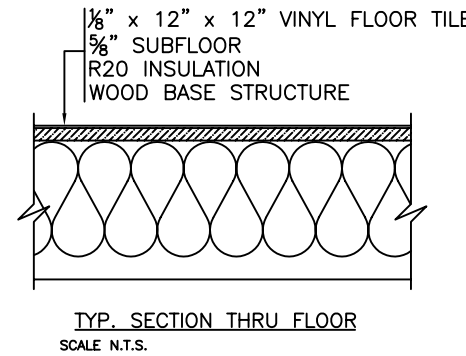


**ELECTRICAL LEGEND**

- ⌘ LIGHT SWITCH
- ⊕ DUPLEX RECEPTACLE
- ▱ 1 x 4 LIGHT FIXTURE
- ▨ 1000 WATT BASEBOARD HEATER
- ▬ 100 AMP 120/240 VOLT PANEL

REVISIONS			
REV	DESCRIPTION	Date	APPROVED

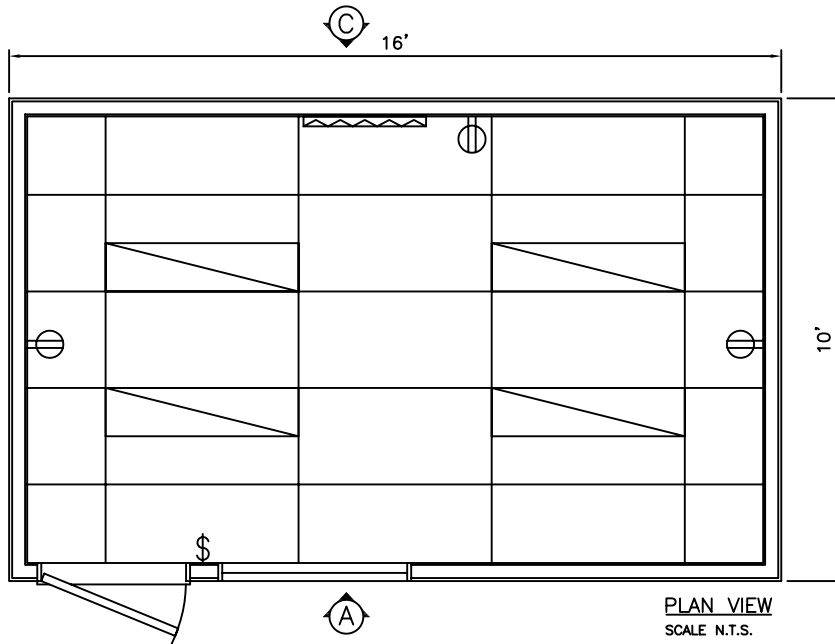

**CUSTOMER:**  
PROVINCIAL PARTITIONS STANDARD

**LOCATION:**  
-

**JOB NAME:**  
10' x 16' EXT. WOOD FRAMED BUILDING

DWG/JOB NO: PPL	BY: FJR
QUOTE NO:	YR MO DY
SHEET NO: 1	06 04 10
SCALE: N.T.S.	REV.NO 0