
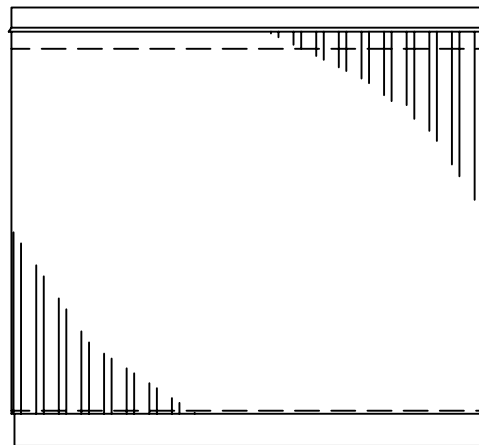
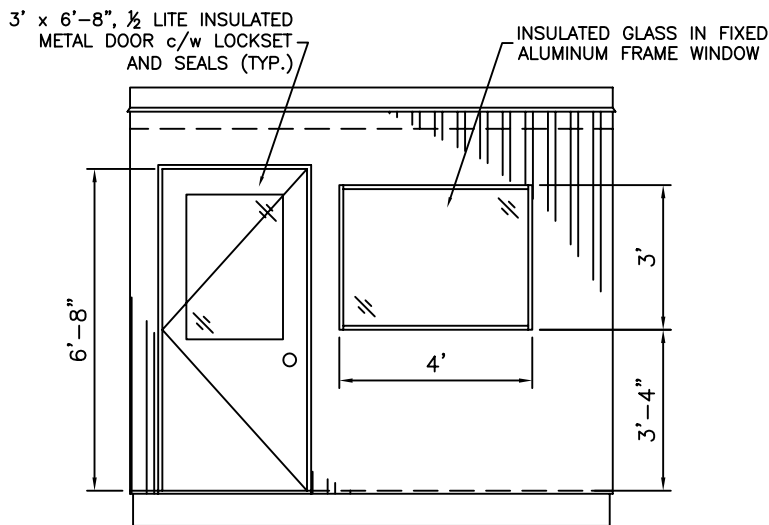
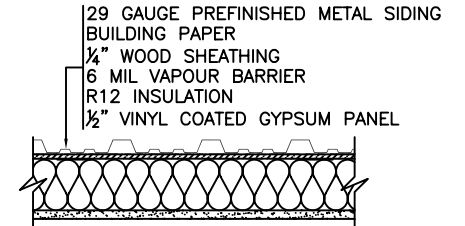
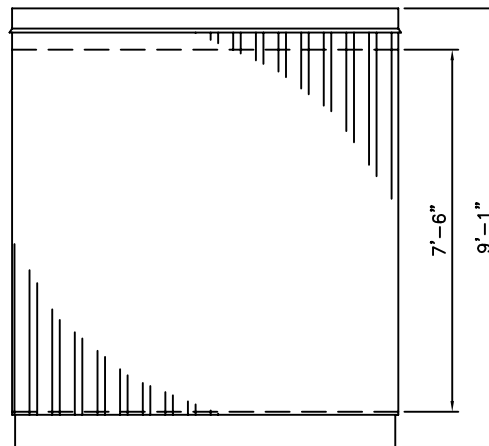
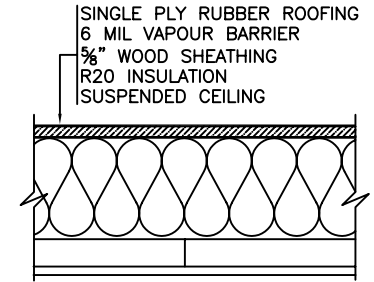
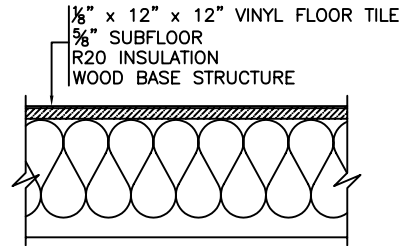


**ELECTRICAL LEGEND**

- ⌘ LIGHT SWITCH
- ⊕ DUPLEX RECEPTACLE
- ▱ 1 x 4 LIGHT FIXTURE
- ▬ 500 WATT BASEBOARD HEATER
- ▬ 100 AMP 120/240 VOLT PANEL

REVISIONS			
REV	DESCRIPTION	Date	APPROVED

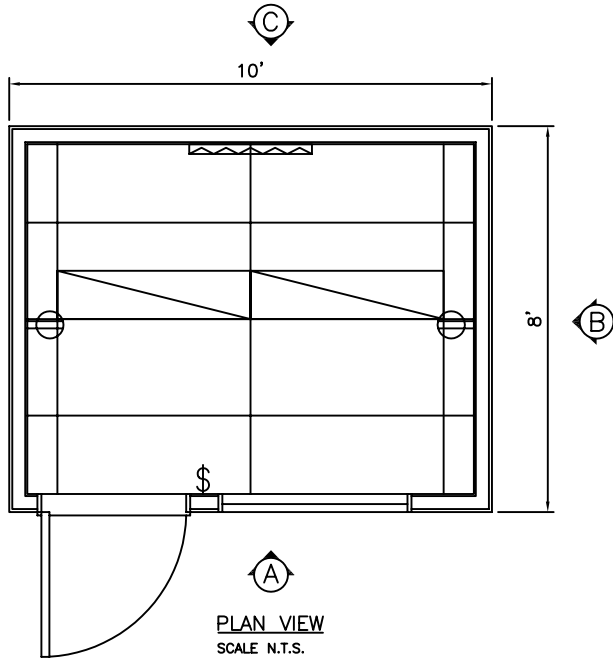

<b>CUSTOMER:</b>			
PROVINCIAL PARTITIONS STANDARD			
<b>LOCATION:</b>			
-			
<b>JOB NAME:</b>			
8' x 10' EXT. WOOD FRAMED BUILDING			
DWG/JOB NO: PPL	BY: FJR		
QUOTE NO:	YR	MO	DY
SHEET NO: 1	06	04	10
SCALE: N.T.S.	REV.NO	0	

