
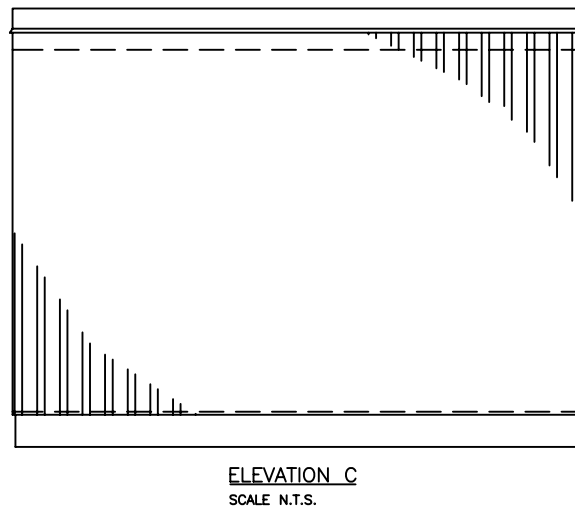
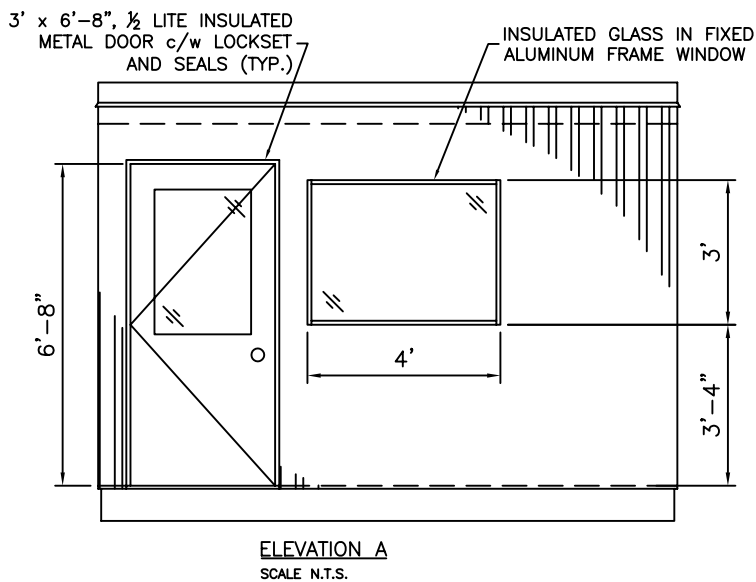
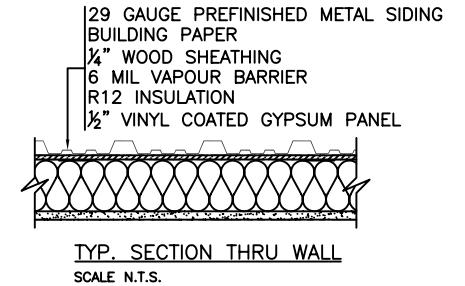
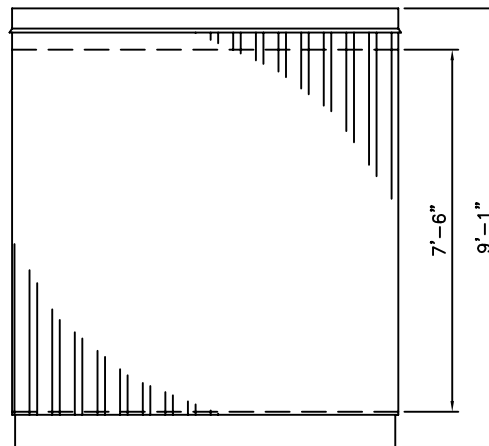
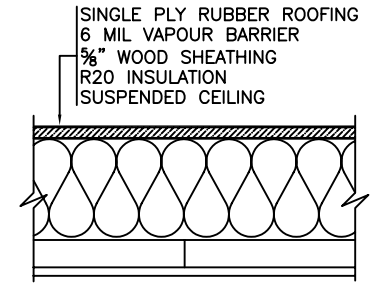
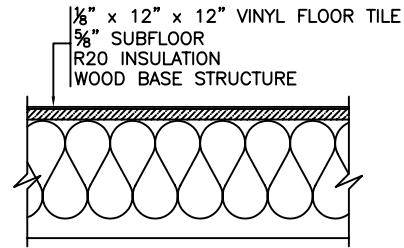


ELECTRICAL LEGEND

- ⌘ LIGHT SWITCH
- ⊕ DUPLEX RECEPTACLE
- ▱ 1 x 4 LIGHT FIXTURE
- ▬ 500 WATT BASEBOARD HEATER
- ▬ 100 AMP 120/240 VOLT PANEL

REVISIONS			
REV	DESCRIPTION	Date	APPROVED

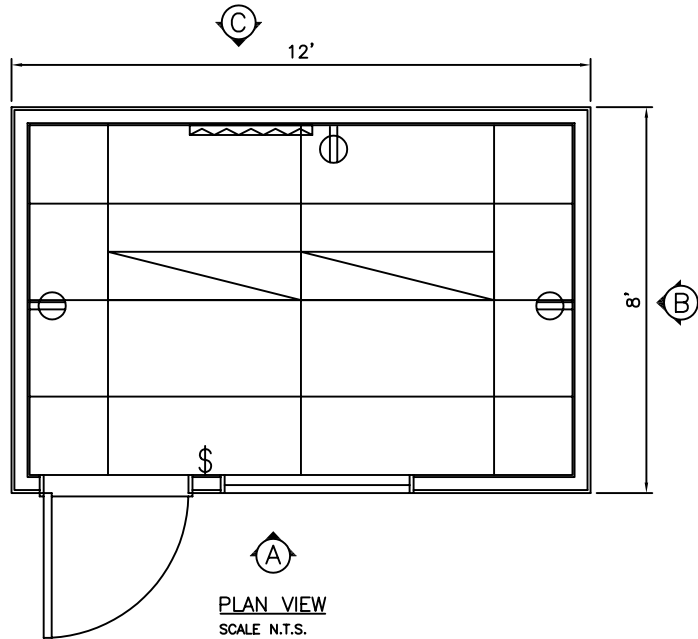

CUSTOMER:			
PROVINCIAL PARTITIONS STANDARD			
LOCATION:			
-			
JOB NAME:			
8' x 12' EXT. WOOD FRAMED BUILDING			
DWG/JOB NO: PPL	BY: FJR		
QUOTE NO:	YR	MO	DY
SHEET NO: 1	06	04	10
SCALE: N.T.S.	REV.NO	0	

